


Section on A -A

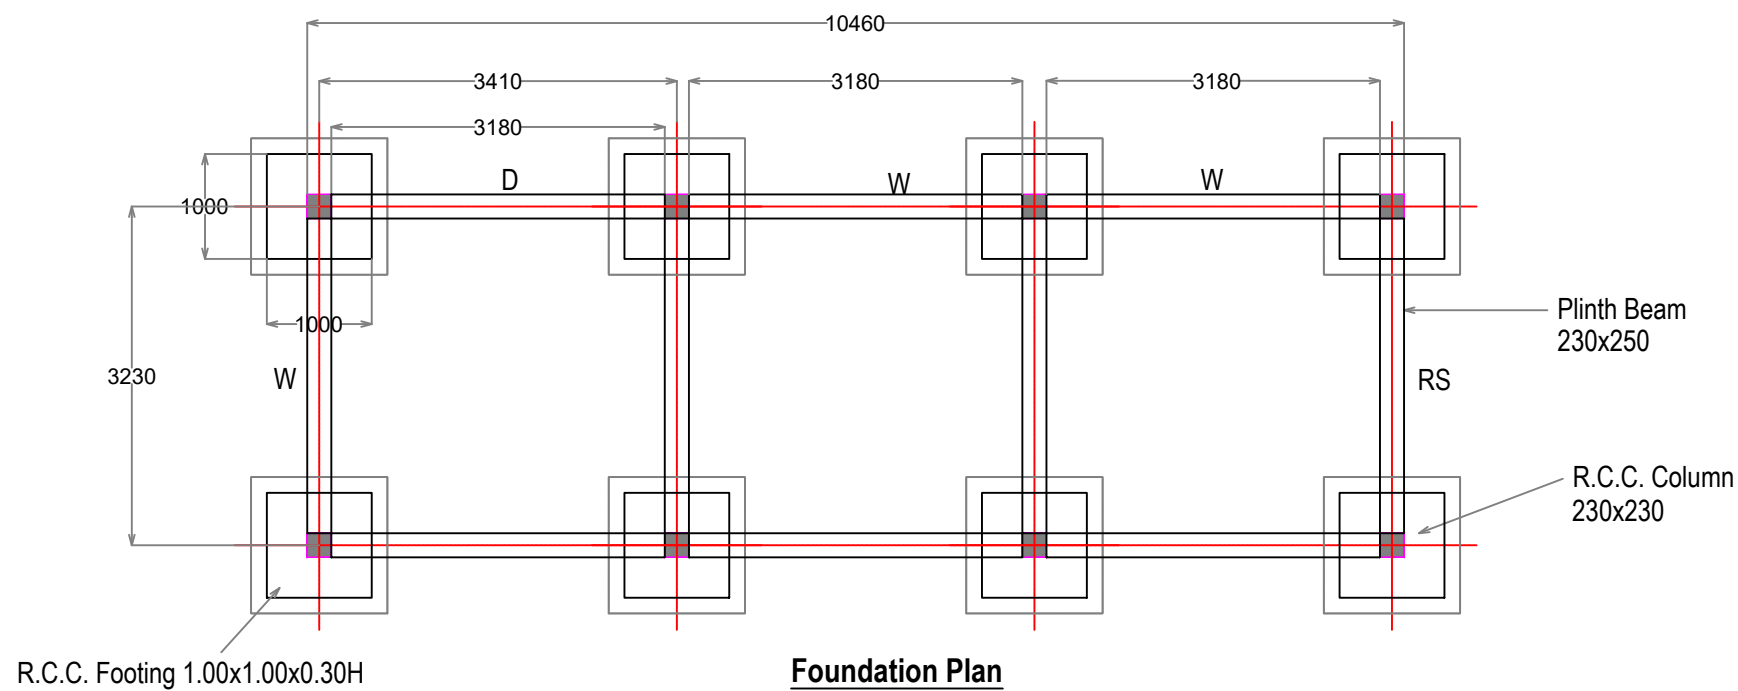

Foundation Plan

Project:	IMPROVEMENT AND MODICATION OF FACILITIES IN EXISTING WATER TREATMENT PLANT AT MAHINDRA WORLD CITY.		
Client:	MAHINDRA WORLD CITY.		
Consultant:	Dr. P. Selvaraj - CHENNAI.		
DRAWN		TITLE:	G.A of Proposed MCC Room 10.0X3.0m
CHECKED			
APPROVED			
DATE			
SCALE	NTS (A3)	DRG NO.	MWC-IWTP-G-015
REVISION	R-0	NO.	
			SHEET NO. 1 of 1